

1

2

3

4

5




Dewberry Engineers Inc.
1479 Town Center Dr
Suite D214
Lakeland, FL 33803
863.345.0838
CA #8794

POLK COUNTY UTILITIES
**NERUSA PRWC AWS
RECEIVING FACILITY**
POLK COUNTY, FLORIDA
PRELIMINARY DESIGN

SEAL

PRELIMINARY DOCUMENTS
NOT FOR CONSTRUCTION

SCALE

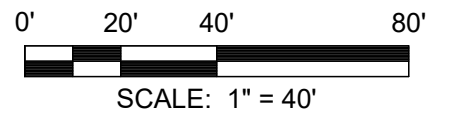

REVISIONS

NO.	DESCRIPTION	DATE

DRAWN BY _____ E.ORTEGA
 APPROVED BY _____ C.MARSH
 CHECKED BY _____ S.GUALTIERI
 DATE _____ AUGUST 2025
 TITLE _____


PROPSD SITE PLAN

PROJECT NO. 50185487

C-102

SHEET NO. 06

C:\PCU\PCU_GEC 24\CSA04_NERUSA AWS Rec Facility\CAD\dwg\50185487 PROPOSED SITE PLAN.dwg PLOTSTYLETABLE: DCS.CTB PLOTTED BY: MARSH, COLSON PLOTTED: 12/19/2025 4:44 PM

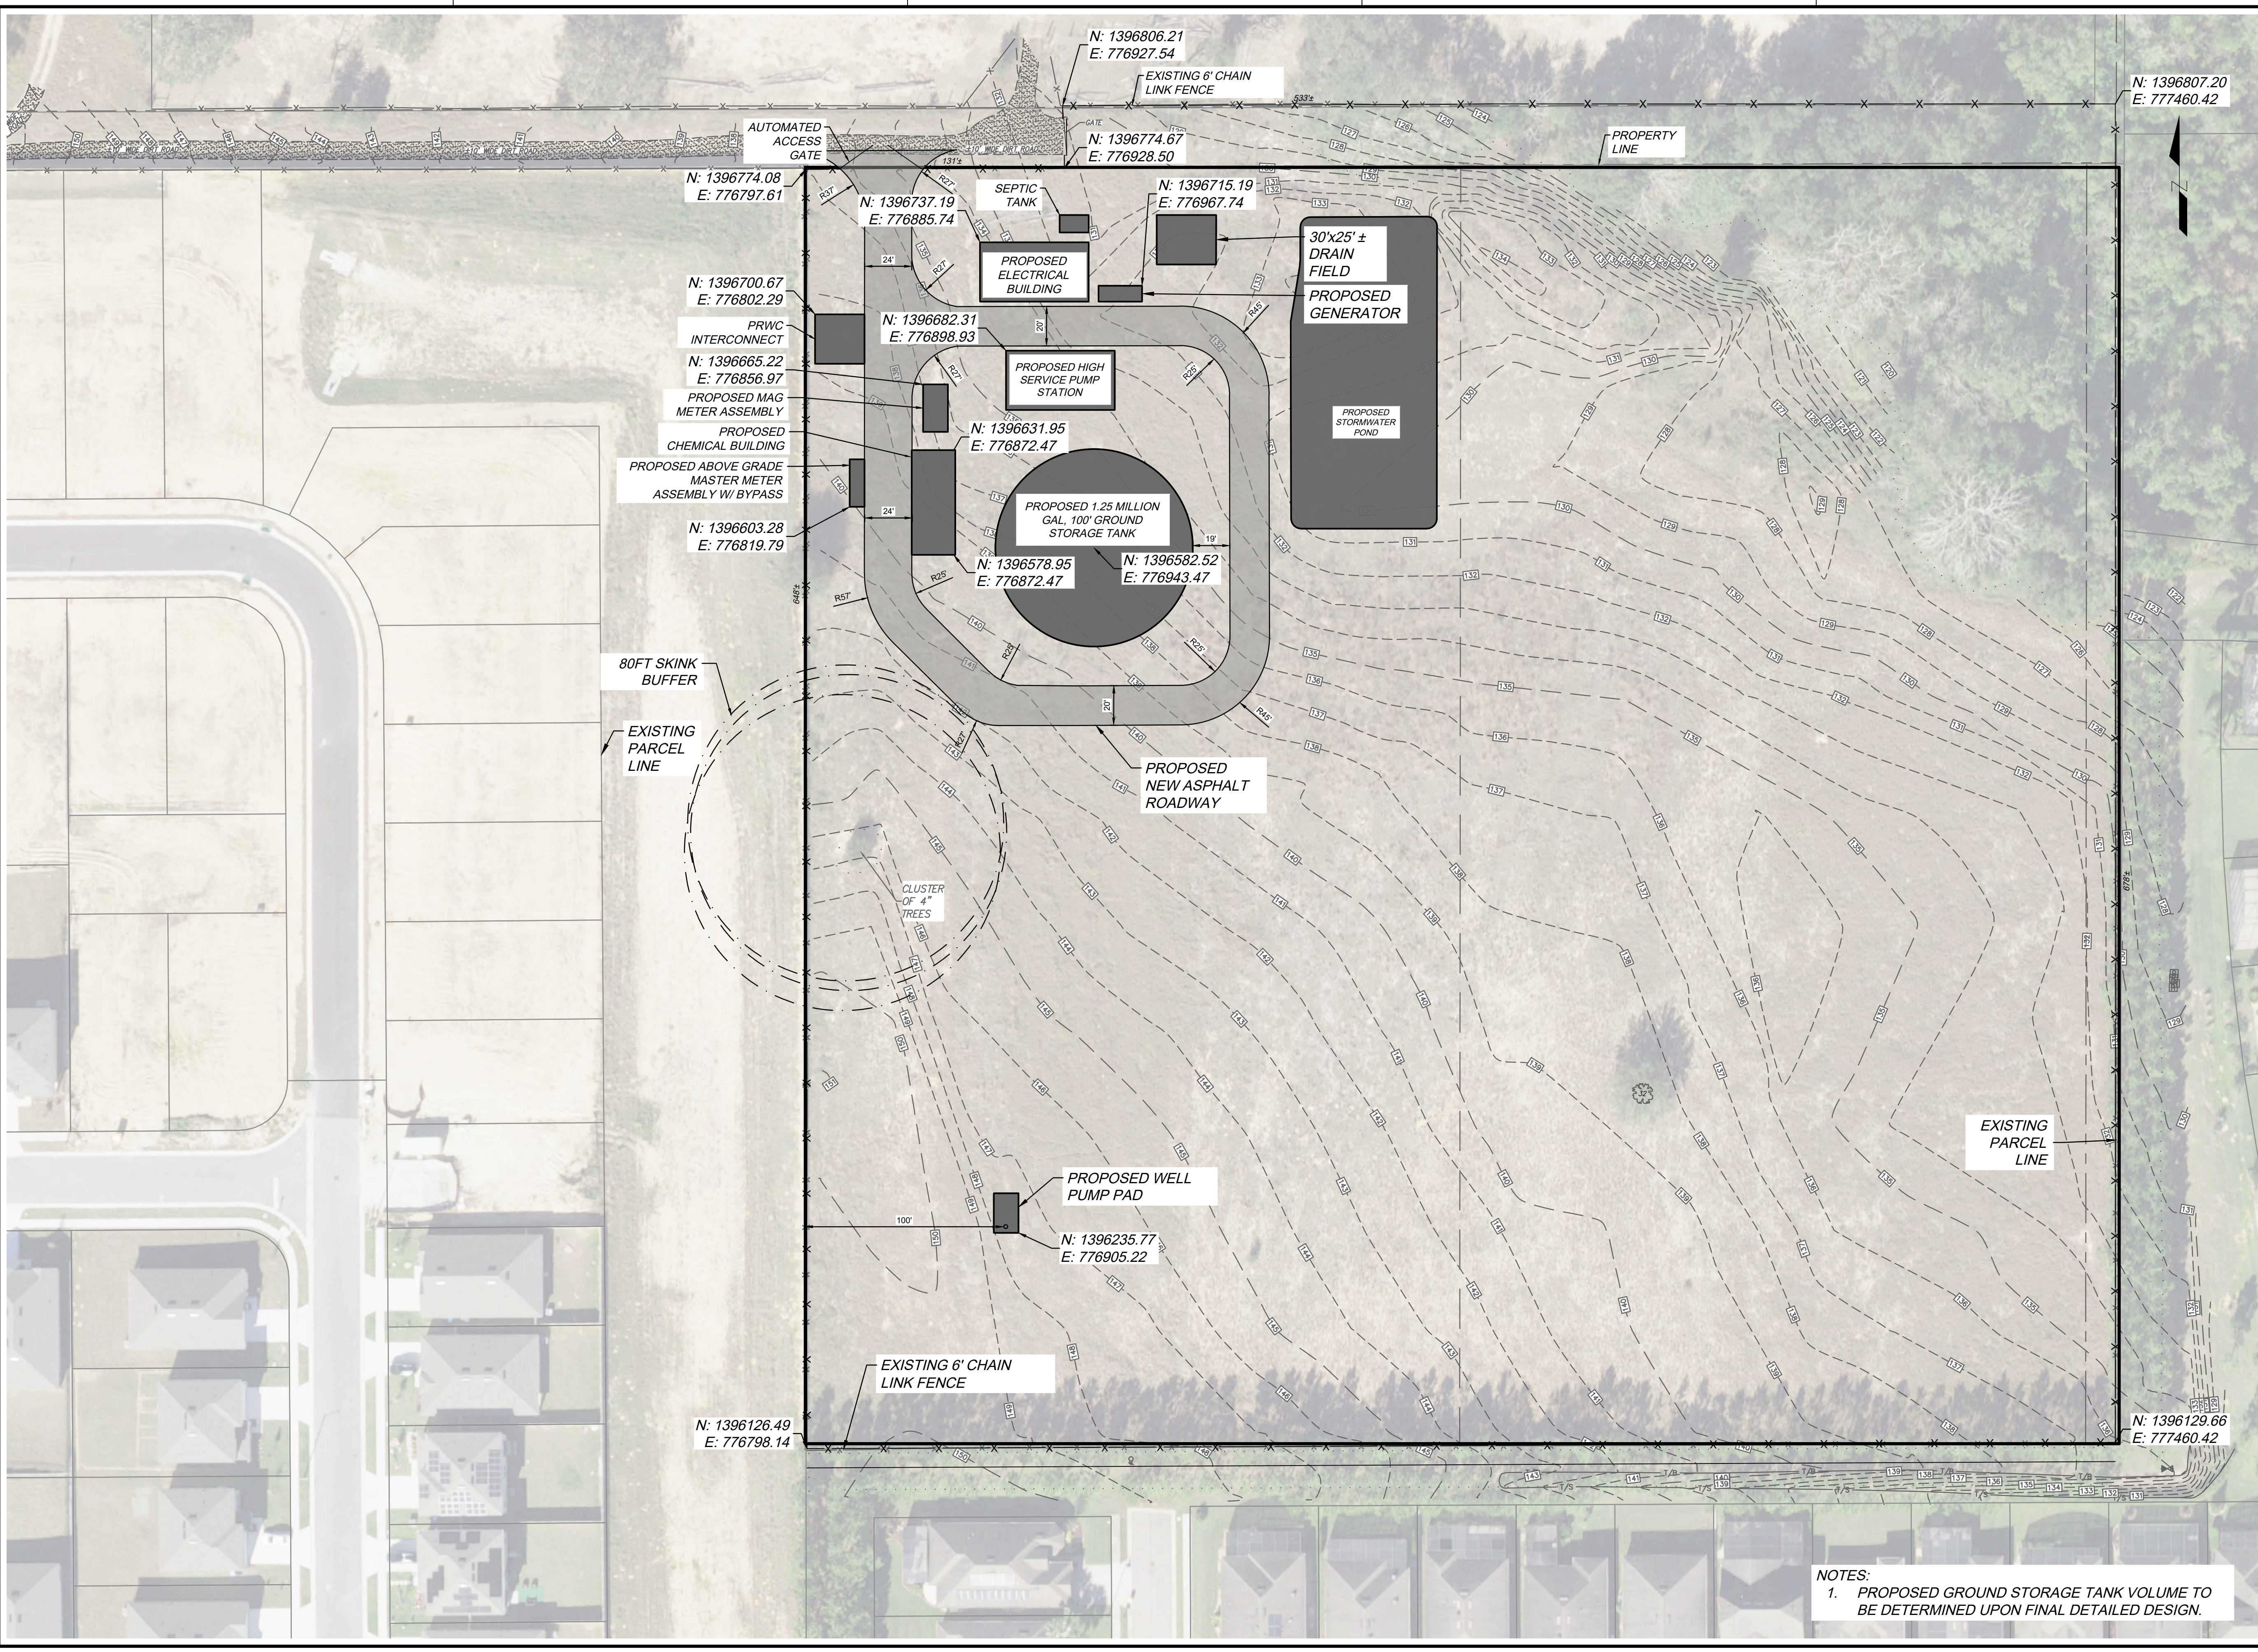

NOTES:
 1. PROPOSED GROUND STORAGE TANK VOLUME TO BE DETERMINED UPON FINAL DETAILED DESIGN.