
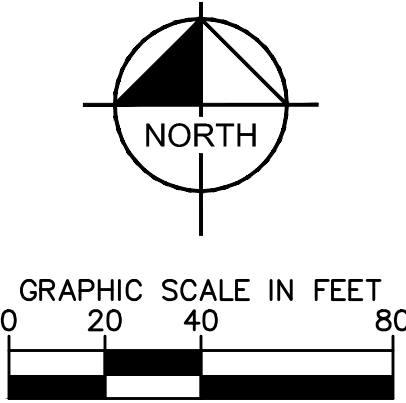


Plotted By: Kleire, David Sheet Set: Kha_Layout; C-110 SITE PLAN January 29, 2025 08:15:01 am K:\LAK_Civil\046376020 - Luz Caloosa Lake Fire Station\CAD\PlanSheets\C-110-SITE.dwg

This document, together with the concepts and designs presented herein, as an instrument of service, is intended only for the specific purpose and client for which it was prepared. Reuse of and improper reliance on this document without written authorization and adaptation by Kimley-Horn and Associates, Inc. shall be without liability to Kimley-Horn and Associates, Inc.

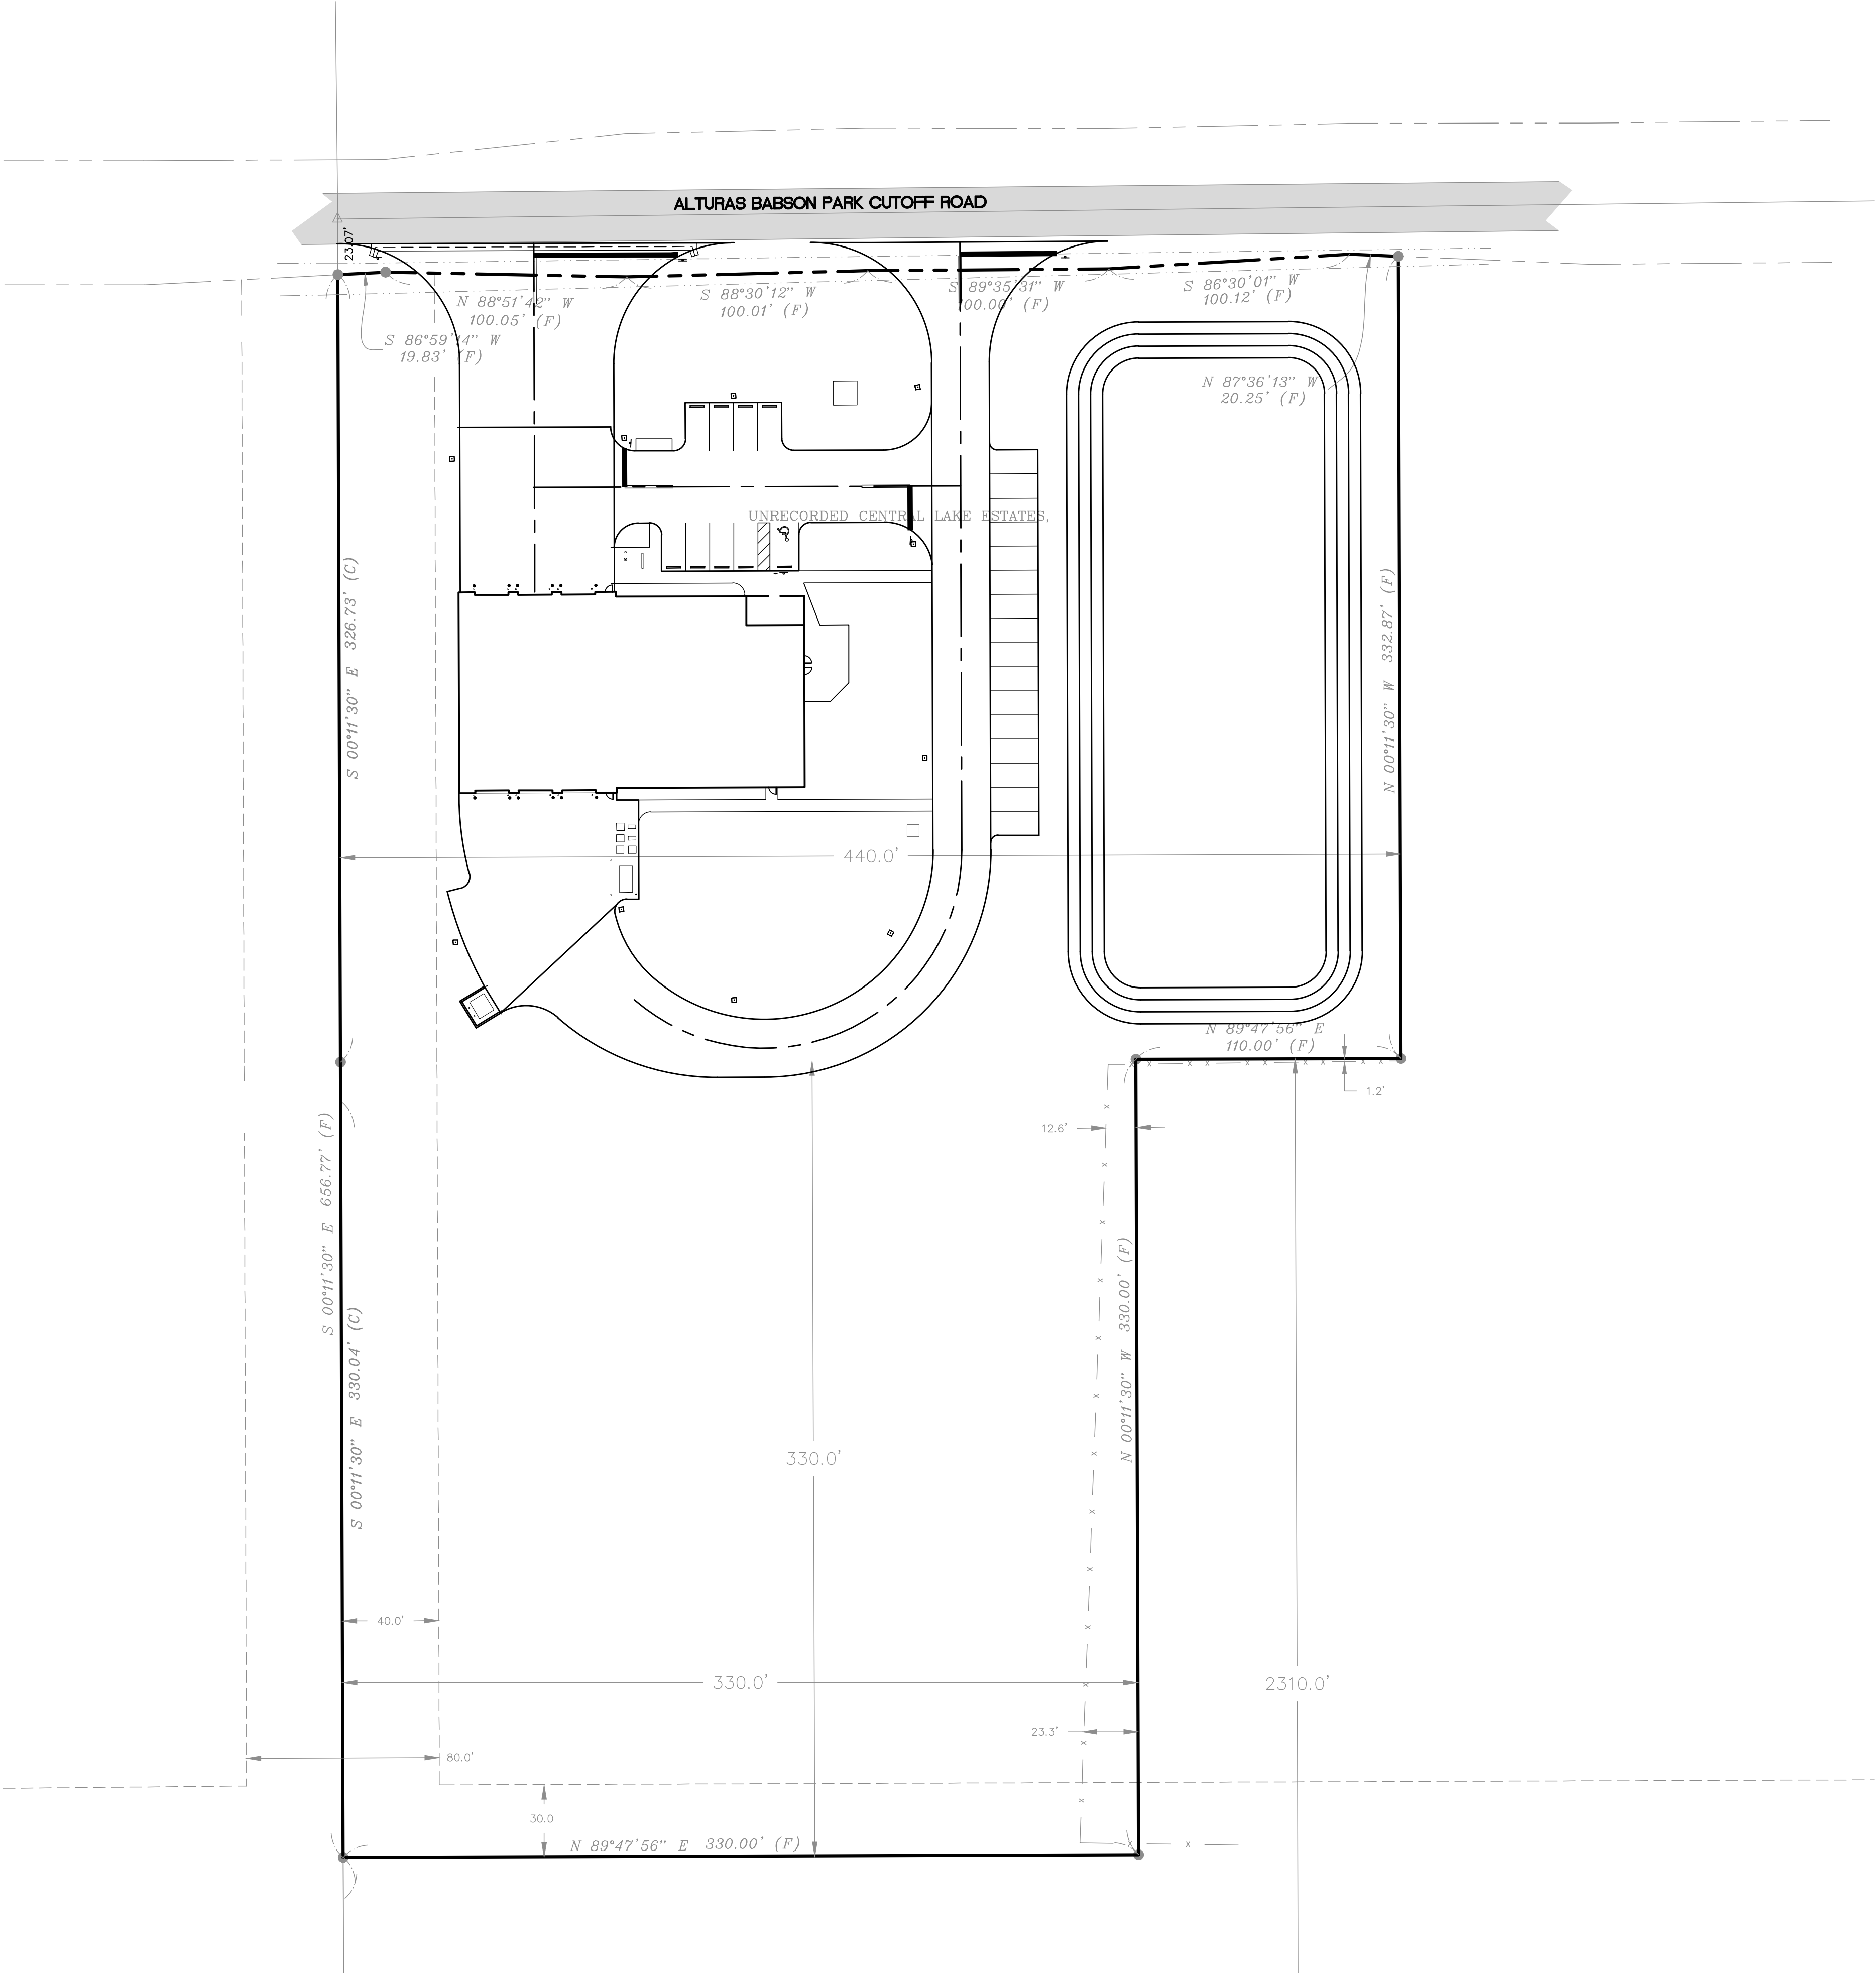

CALOOSA LAKE FIRE STATION PREPARED FOR THE LUNZ GROUP POLK COUNTY FLORIDA				SHEET NUMBER C-110				Kimley»Horn © 2025 KIMLEY-HORN AND ASSOCIATES, INC. 109 SOUTH KENTUCKY AVENUE, LAKELAND FL, 33801 PHONE: 863-701-8702 WWW.KIMLEY-HORN.COM REG NO.: 35106				No.		REVISIONS		DATE		BY	
SITE PLAN				KHA PROJECT 046376020		DATE Jan 2025		LICENSED PROFESSIONAL		PE NAME		FLORIDA LICENSE NUMBER		PE NUMBER		DATE: JAN 29 2025			
				SCALE AS SHOWN		—		DESIGNED BY		—		DRAWN BY		—		CHECKED BY		—	